


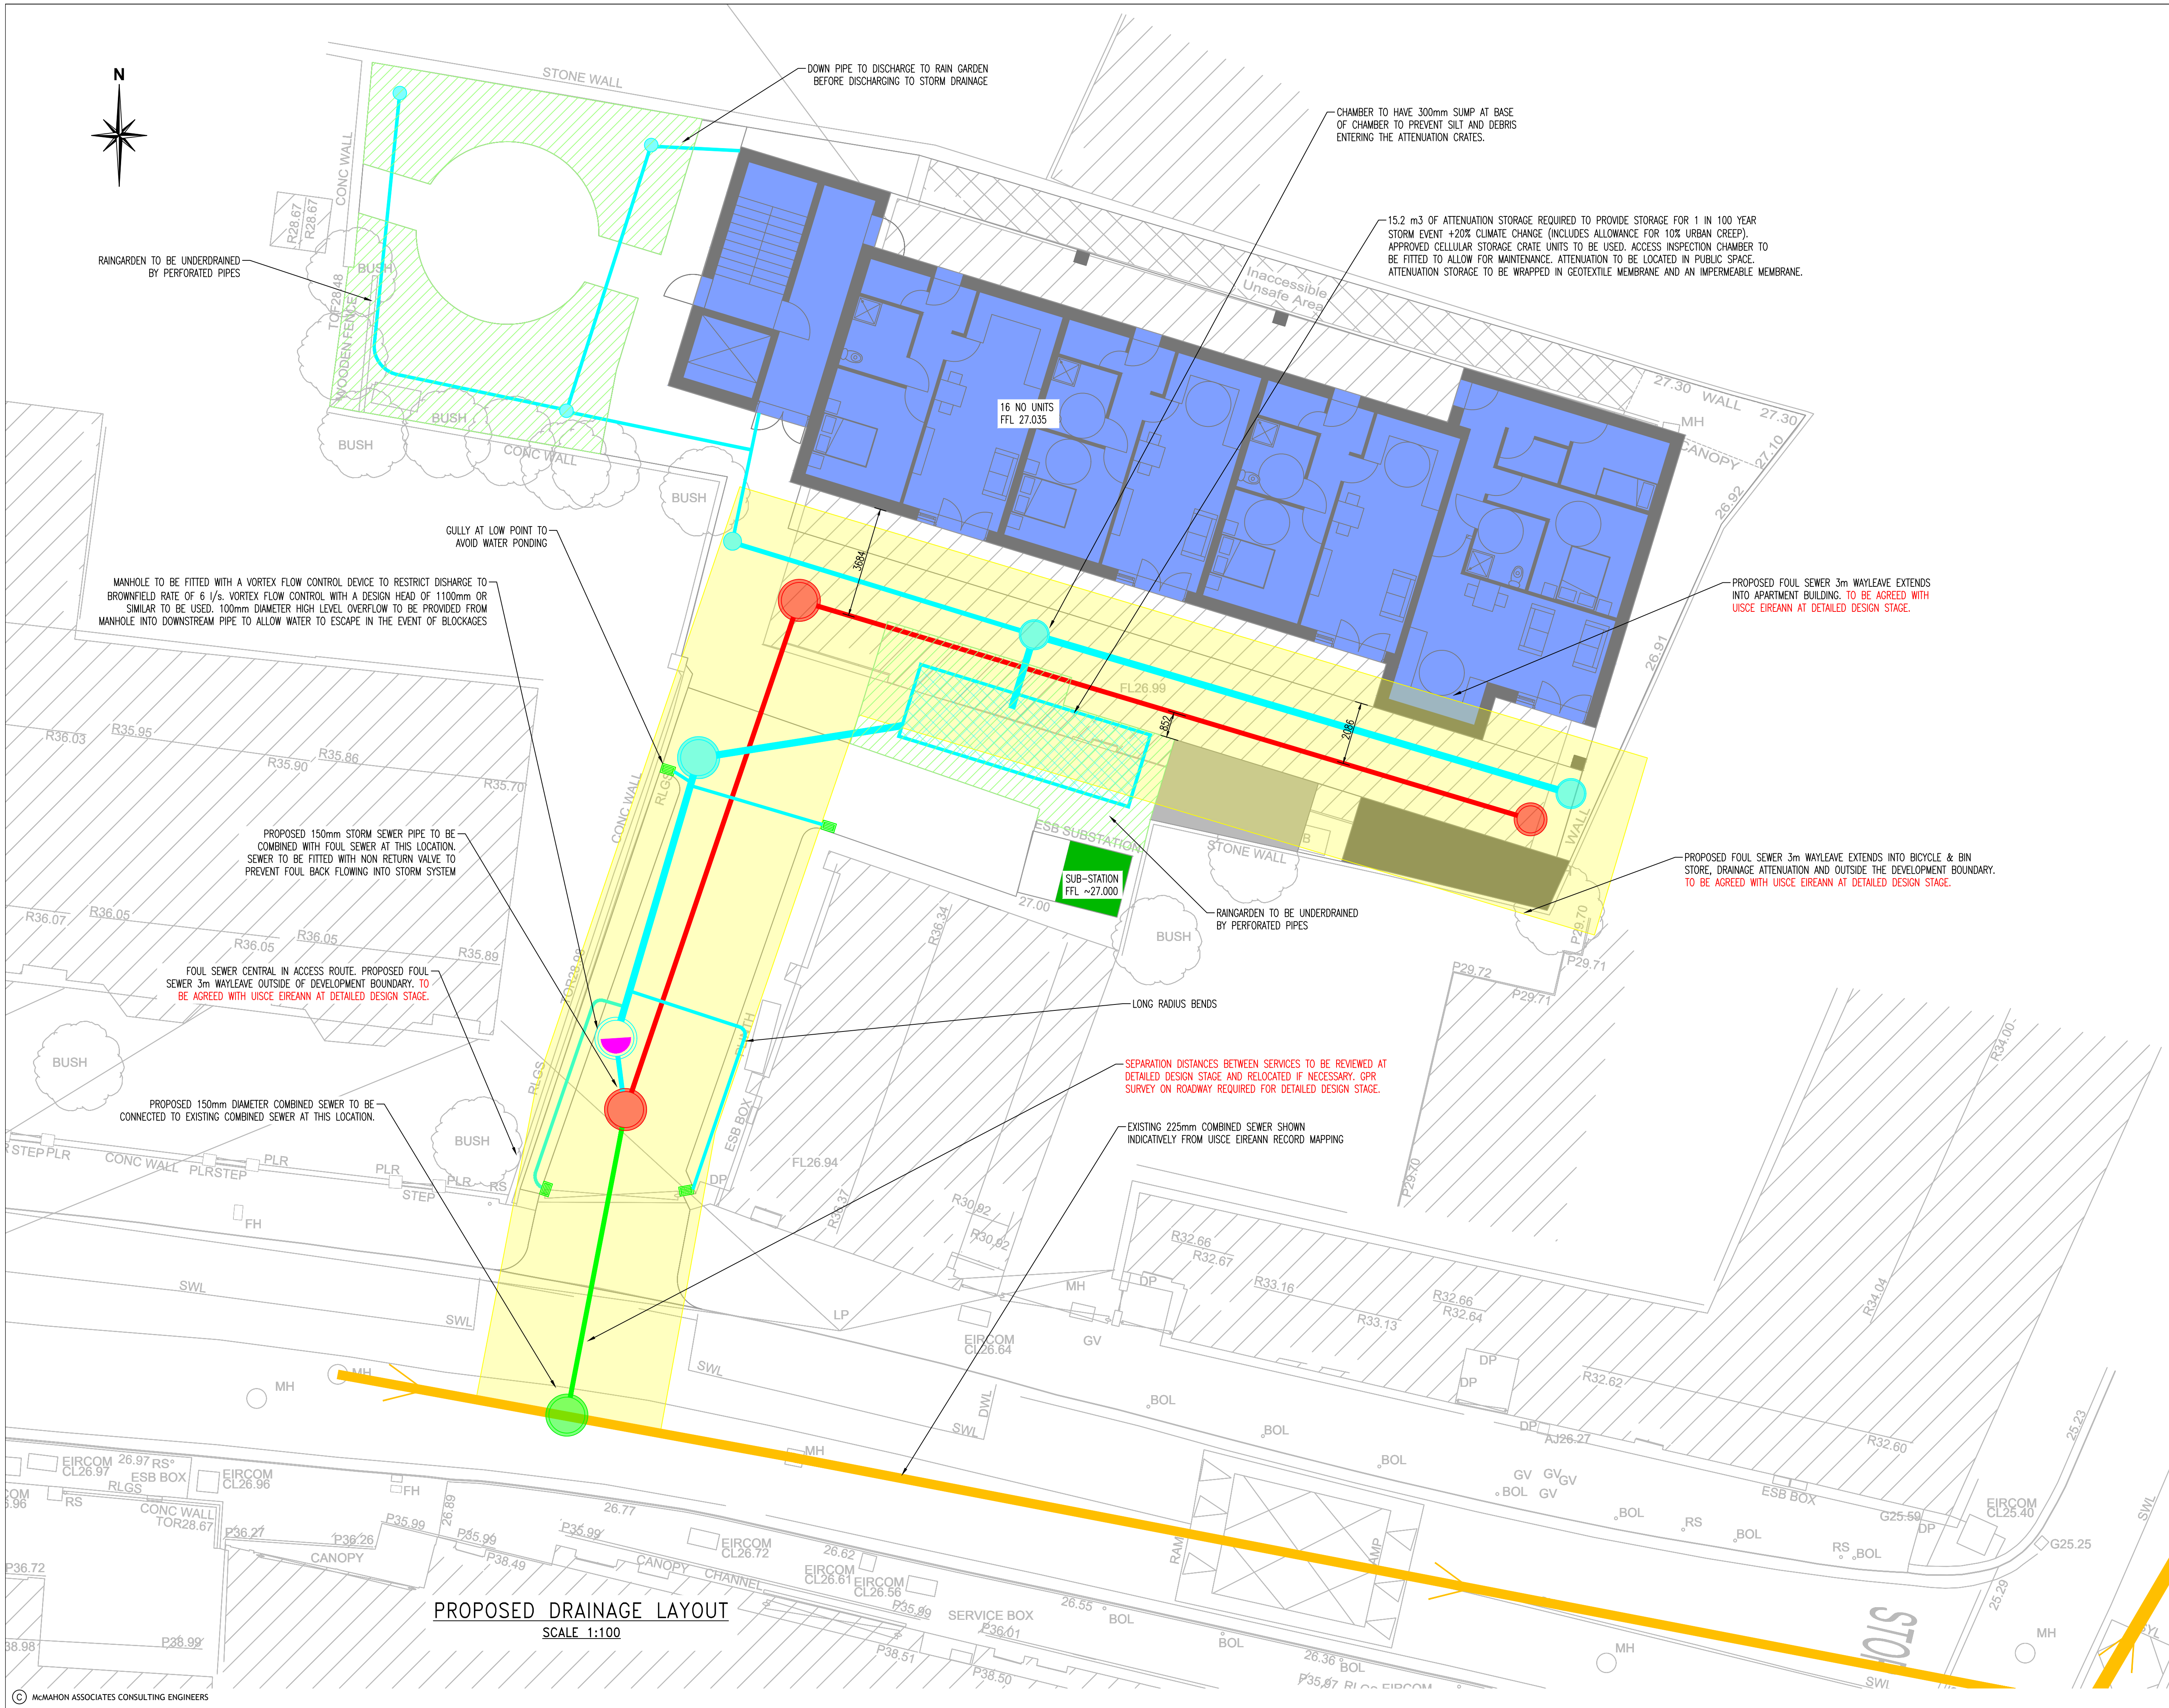

GENERAL NOTES:

1. ALL DIMENSIONS AND LEVELS TO BE VERIFIED ON SITE PRIOR TO COMMENCEMENT OF THE WORKS. ANY DISCREPANCIES TO BE REPORTED TO THE ENGINEER.
2. THIS DRAWING IS TO BE READ IN CONJUNCTION WITH THE RELEVANT ARCHITECT'S AND OTHER ENGINEERING DRAWINGS.

DRAINAGE NOTES:

1. ALL FOUL DRAINAGE INFRASTRUCTURE TO BE CONSTRUCTED IN ACCORDANCE WITH IRISH WATERS REQUIREMENTS AND THEIR CONSTRUCTION DETAIL IW-CDS-5030-01 AUGUST 2025 REVISION 5.
2. ALL DRAINAGE WORK TO BE CARRIED OUT IN ACCORDANCE WITH "WICKLOW COUNTY DEVELOPMENT PLAN", "CIVIL ENGINEERING SPECIFICATION FOR THE WATER INDUSTRY 6TH EDITION" AND "GREATER DUBLIN REGIONAL CODE OF PRACTICE FOR DRAINAGE WORKS"
3. ALL DRAINAGE CONNECTIONS FROM BUILDINGS TO CONFIRM TO THE BUILDING REGULATIONS 2010, PART H.

DRAINAGE LEGEND

- PROPOSED BUILDING
- INDICATIVE 150mm Ø FOUL NETWORK
- INDICATIVE 150/225mm Ø STORM NETWORK
- INDICATIVE SIZING OF PROPOSED ATTENUATION TANK
- EXISTING 225/450mm Ø COMBINED SEWER
- PROPOSED 150mm COMBINED SEWER
- PROPOSED STORM MANHOLE WITH VORTEX FLOW CONTROL
- GULLY
- FOUL SEWER 3m WAYLEAVE
- RAINGARDEN

REV	DATE	DESCRIPTION	BY	APP
A	06.08.26	MINOR UPDATE	SMC	PMG

DRAWING STATUS:
PART_8_PLANNING

CLIENT:
WICKLOW COUNTY COUNCIL

ARCHITECT:
WICKLOW COUNTY COUNCIL

JOB DESCRIPTION:
16 NO. UNIT APARTMENT DEVELOPMENT, PARNELL ROAD, BRAY, CO. WICKLOW

DRAWING TITLE:
PROPOSED DRAINAGE LAYOUT

PROJECT No.:	DRAWING No.:
P-3953	C-02

SCALE:	SHEET:	DATE:
1:100	A1	19.03.26

DRAWN BY:	CHECKED BY:	APPROVED BY:
SMC	PMG	MK

McMahon Associates
Consulting Civil & Structural Engineers, Project Managers
Environmental Engineers, PSDP & Traffic Engineers
The Mill Building, Newtown Link Road, Greenhills, Drogheda, Co. Louth
t: 041 4141 383 e: info@mcmahonengineers.com